

SYMBOLS

	SIM PLAN DETAIL REFERENCE - 1 = Detail Number A101 = Sheet Number
	DOOR TAG (See Door Schedule)
	Ref INTERIOR ELEVATION REFERENCE A101 = Sheet Number 1 = Detail Number Ref = Detail Name
	Ref EXTERIOR ELEVATION REFERENCE A101 = Sheet Number 1 = Detail Number Ref = Detail Name
	BUILDING LEVEL REFERENCE
	REVISION TAG
	Room name ROOM REFERENCE- (See Room Schedule) 101 = Room Number
	SIM SECTION CALLOUT HEAD - 1 = Detail Number A101 = Sheet Number
	SIM DETAIL REFERENCE TAIL - 1 = Detail Number A101 = Sheet Number
	SECTION TAIL - Shows Direction of Section View
	ELEVATION TAG
	WALL TAG (See Wall Schedule)
	WINDOW TAG (See Window Schedule)
	BUILDING INSULATION - REFER TITLE 24

ELECTRICAL LEGEND

- DUPLEX RECEPTACLE - ARC FAULT DEVICES - GR / GFCI TYPICAL ALL RECEPTACLES
 - FOURPLEX RECEPTACLE
 - 4" LED DOWNLIGHT - IC AT JAB RATED - REFER TABLE 150.0A A0 02
 - 2" LED DOWNLIGHT - IC AT JAB RATED - REFER TABLE 150.0A A0 02
 - WALL MOUNTED FIXTURE
 - DROPPED PENDANT FIXTURE
 - SINGLE POLE SWITCH
 - 3-WAY, 4-WAY SWITCH
 - WATER PROOF
 - EXHAUST FAN WITH 5 AIR CHANGES PER HOUR
 - SMOKE DETECTOR
 - CARBON MONOXIDE
- NOTE: RECEPTACLES SHALL BE TAMPER RESISTANT


- CEILING FAN
- MECHANICAL WALL REGISTER - 6" X 12"
- HANGING LIGHT FIXTURE

NOTE: ALL ELECTRICAL IS SCHEMATIC AND NOT NECESSARILY EXACT.
ELECTRICAL CONTRACTOR SHALL REVIEW ALL ELECTRICAL WITH OWNERS
PRIOR TO INSTALLATION.

WALL LEGEND	
EXISTING TO REMAIN	
EXISTING TO BE REMOVED	
NEW WALL TO BE BUILT	


TABLE 6-1: SUMMARY OF COMPLIANT LUMINAIRE TYPES

HIGH EFFICACY LUMINAIRES	JAB HIGH EFFICACY LIGHTING LAMPS AND LIGHT SOURCES THAT MUST BE JAB-CERTIFIED.	RECESSED DOWNLIGHT LUMINAIRES IN CEILING
ON-BASED LINEAR FLUORESCENT, PIN-BASED COMPACT FLUORESCENT, FLUO-START METAL HALIDE, HIGH PRESSURE SODIUM, GU-24 OTHER THAN LED'S, INSEPARABLE S&L LUMINAIRES WITH COLORED LIGHT SOURCES FOR DECORATIVE LIGHTING PURPOSE.	LED LIGHT SOURCES IN CEILING RECESSED DOWNLIGHT LUMINAIRES, LED LUMINAIRES WITH INTEGRAL SOURCES, SCREW-BASED LED LAMPS (A-LAMPS, PAR LAMPS, ETC.), PIN-BASED LED LAMPS (MR-16, AR-111, ETC.), GU-24 BASED LED LIGHT SOURCE, ANY SOURCE OR LUMINAIRE NOT LISTED ELSEWHERE ON THIS TABLE.	SHALL NOT HAVE SCREW BASED SOCKETS, SHALL CONTAIN JAB-CERTIFIED LIGHT SOURCES, SHALL MEET ALL PERFORMANCE REQUIREMENTS IN 150.0 (C) I.C.

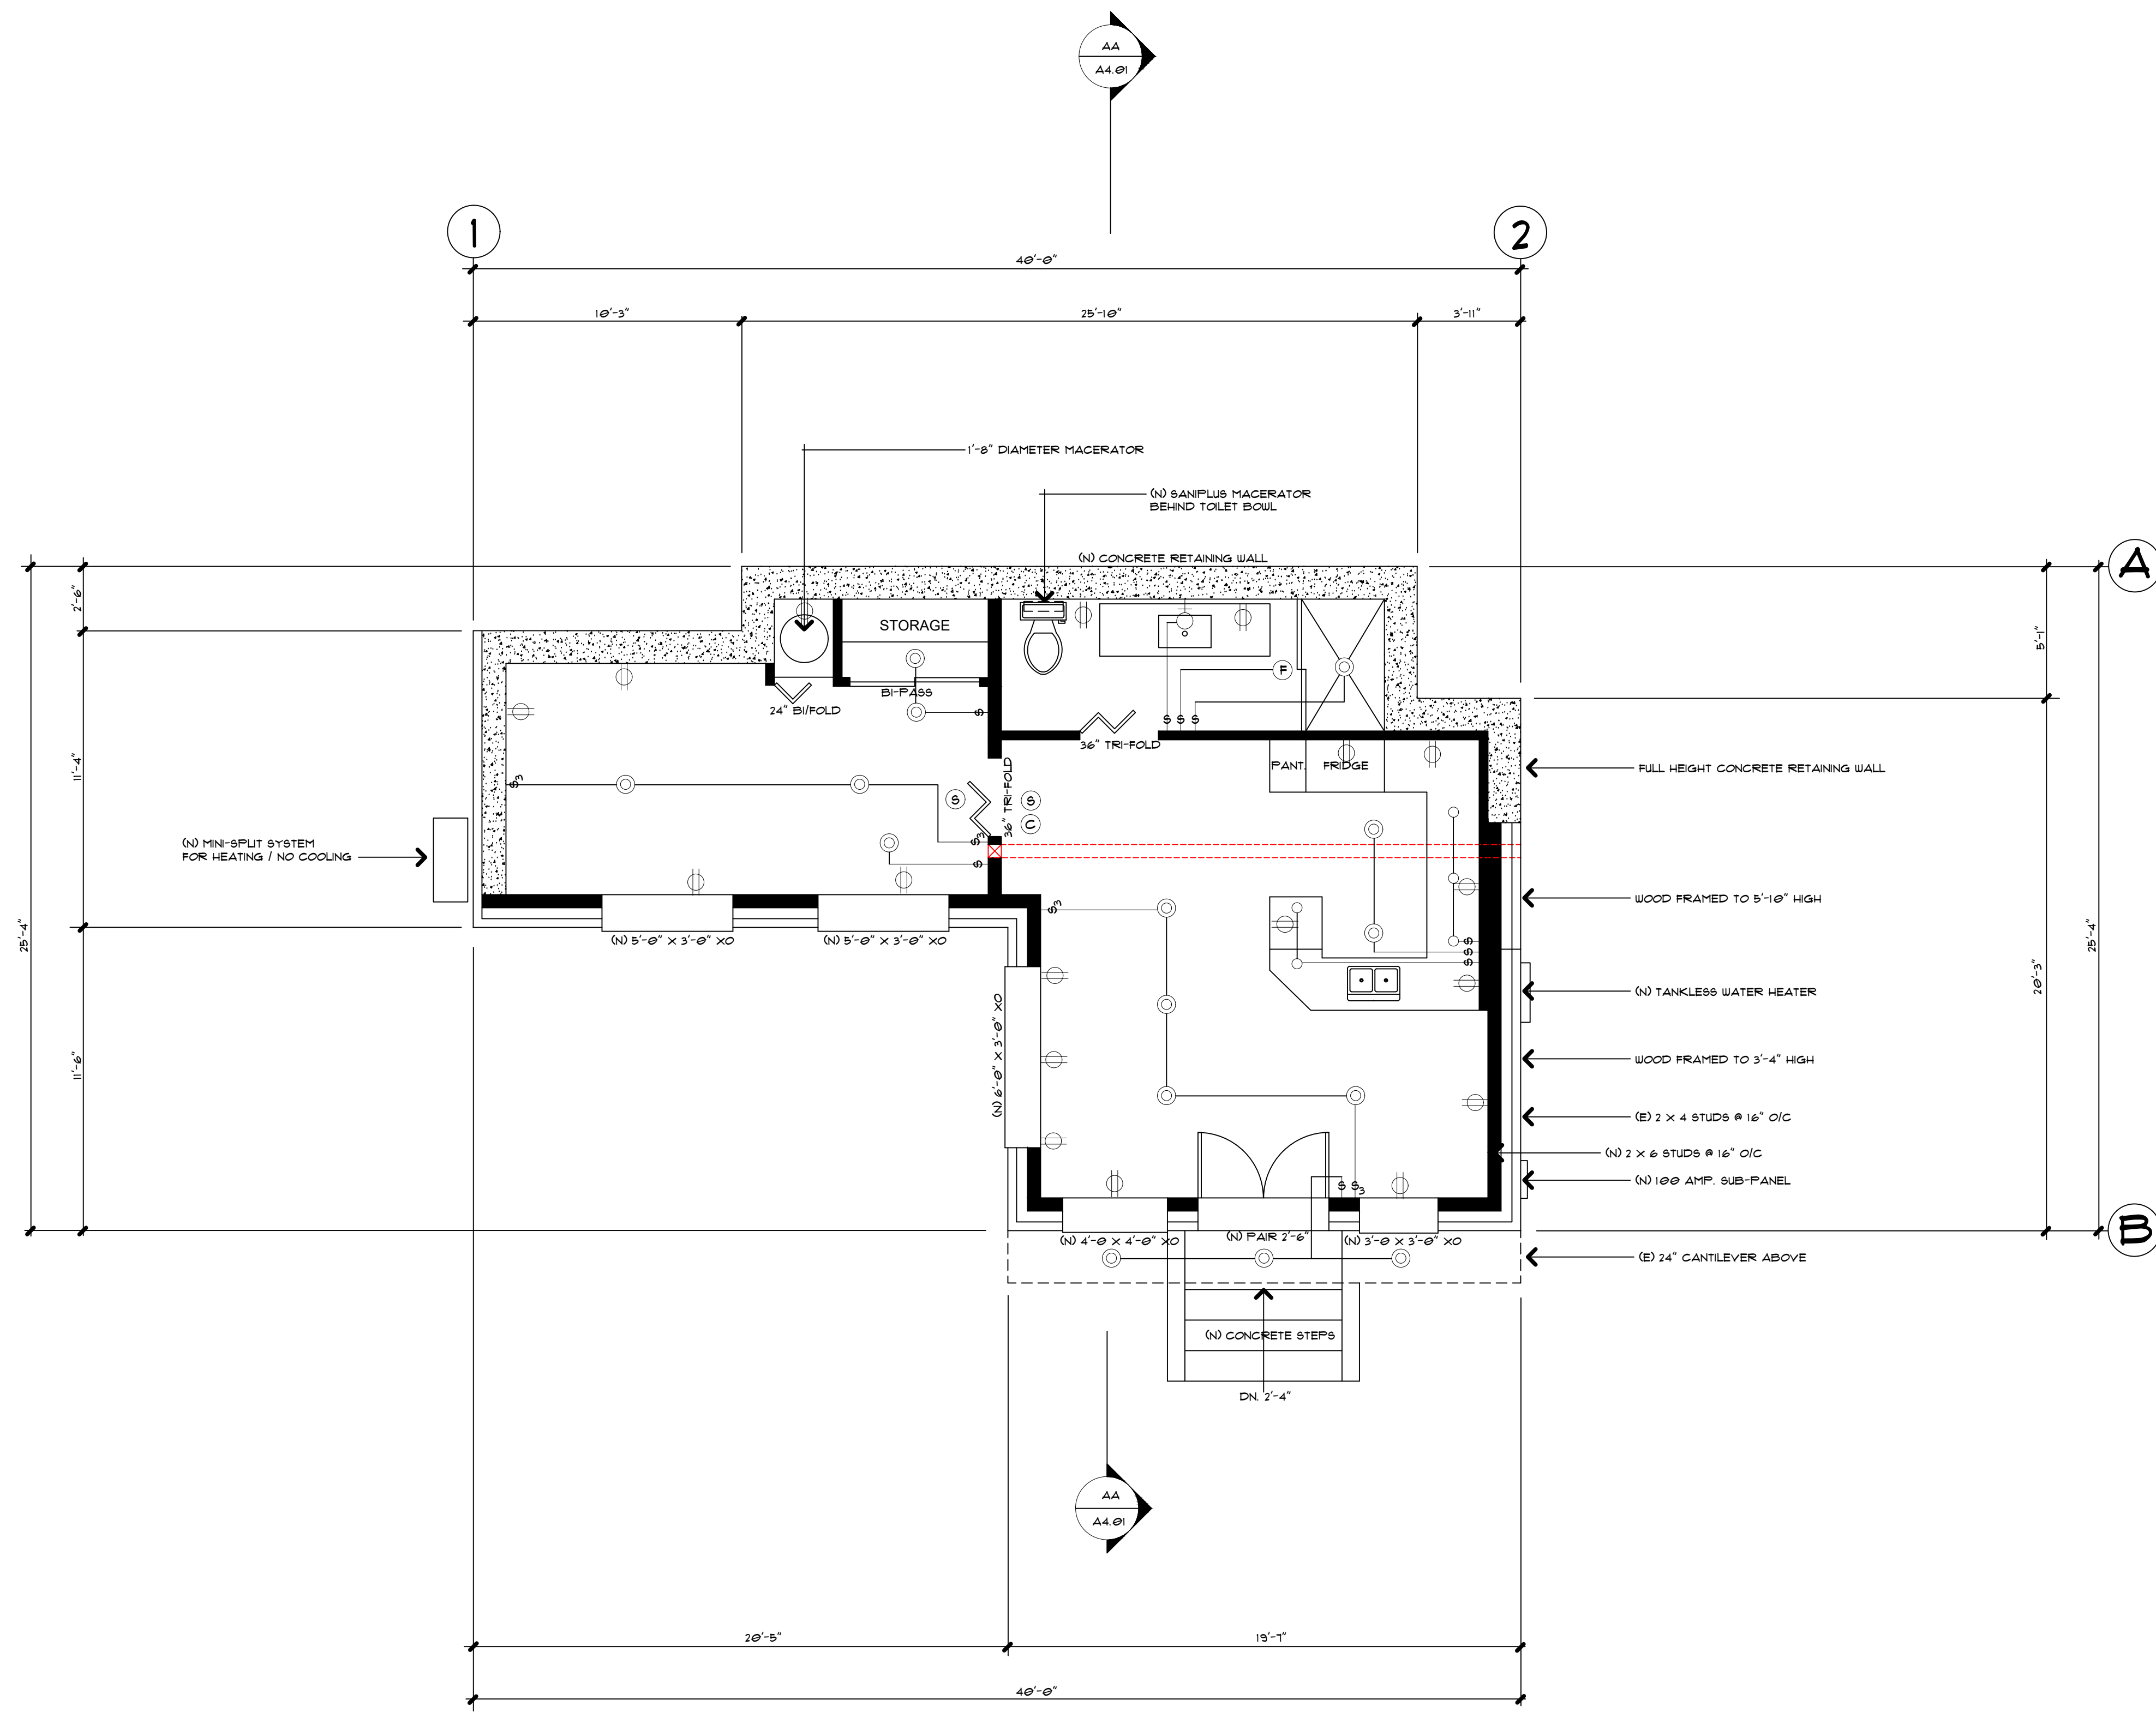

LOWER LEVEL FLOOR PLAN

SCALE: 1/4" = 1'-0"

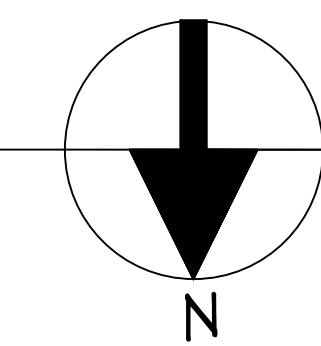


DESIGNED BY: D.C. FOOTE, INCORPORATED (805) 444-1230 DCFOOTE@DCFOOTE.COM

REVISIONS	BY

ASSOCIATE MEMBER OF
AMERICAN INSTITUTE OF ARCHITECTS

D.C.FOOTE - ASSOCIATE AIA

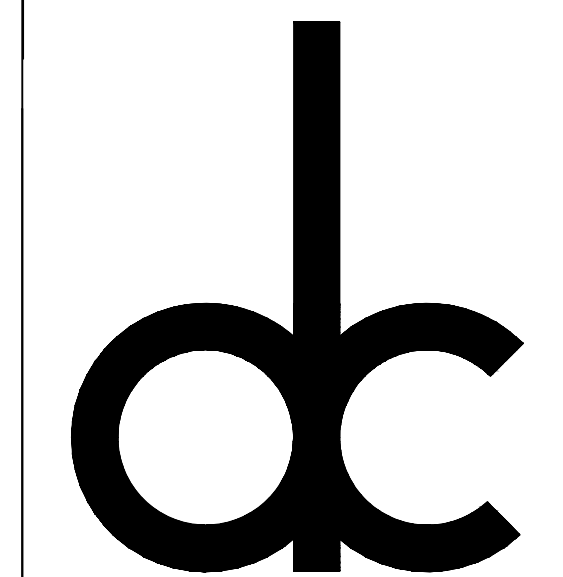

CELL: (805) 444-1230
OFFICE: (805) 482-0091
TOLL FREE: (888) DCFOOTE
FAX: (805) 482-5125
DCFOOTE@DCFOOTE.COM

D.C.FOOTE, INCORPORATED
501 MOBIL AVENUE, SUITE A
CAMARILLO, CALIFORNIA 93010
PHONE (805) 444-1230
DCFOOTE@DCFOOTE.COM
WWW.DCFOOTE.COM

ELECTRICAL PLAN
PROJECT TITLE
PROPOSED LOWER LEVEL ADU
CAMARILLO, CALIFORNIA

JOB NUMBER
123919

DRAWN BY: D.C.FOOTE

CHECKED: JDF

DATE: AUGUST 19, 2021

SCALE: NOTED

SHEET

A4.01